



File Name: C:\DMS\Revit\_Projects\Optimum Personal Care- Phase 2-FLBG\_paul.corley.rvt  
 Author: paul.corley  
 User: paul.corley  
 Date/Time: 2/13/2019 1:38:56 PM

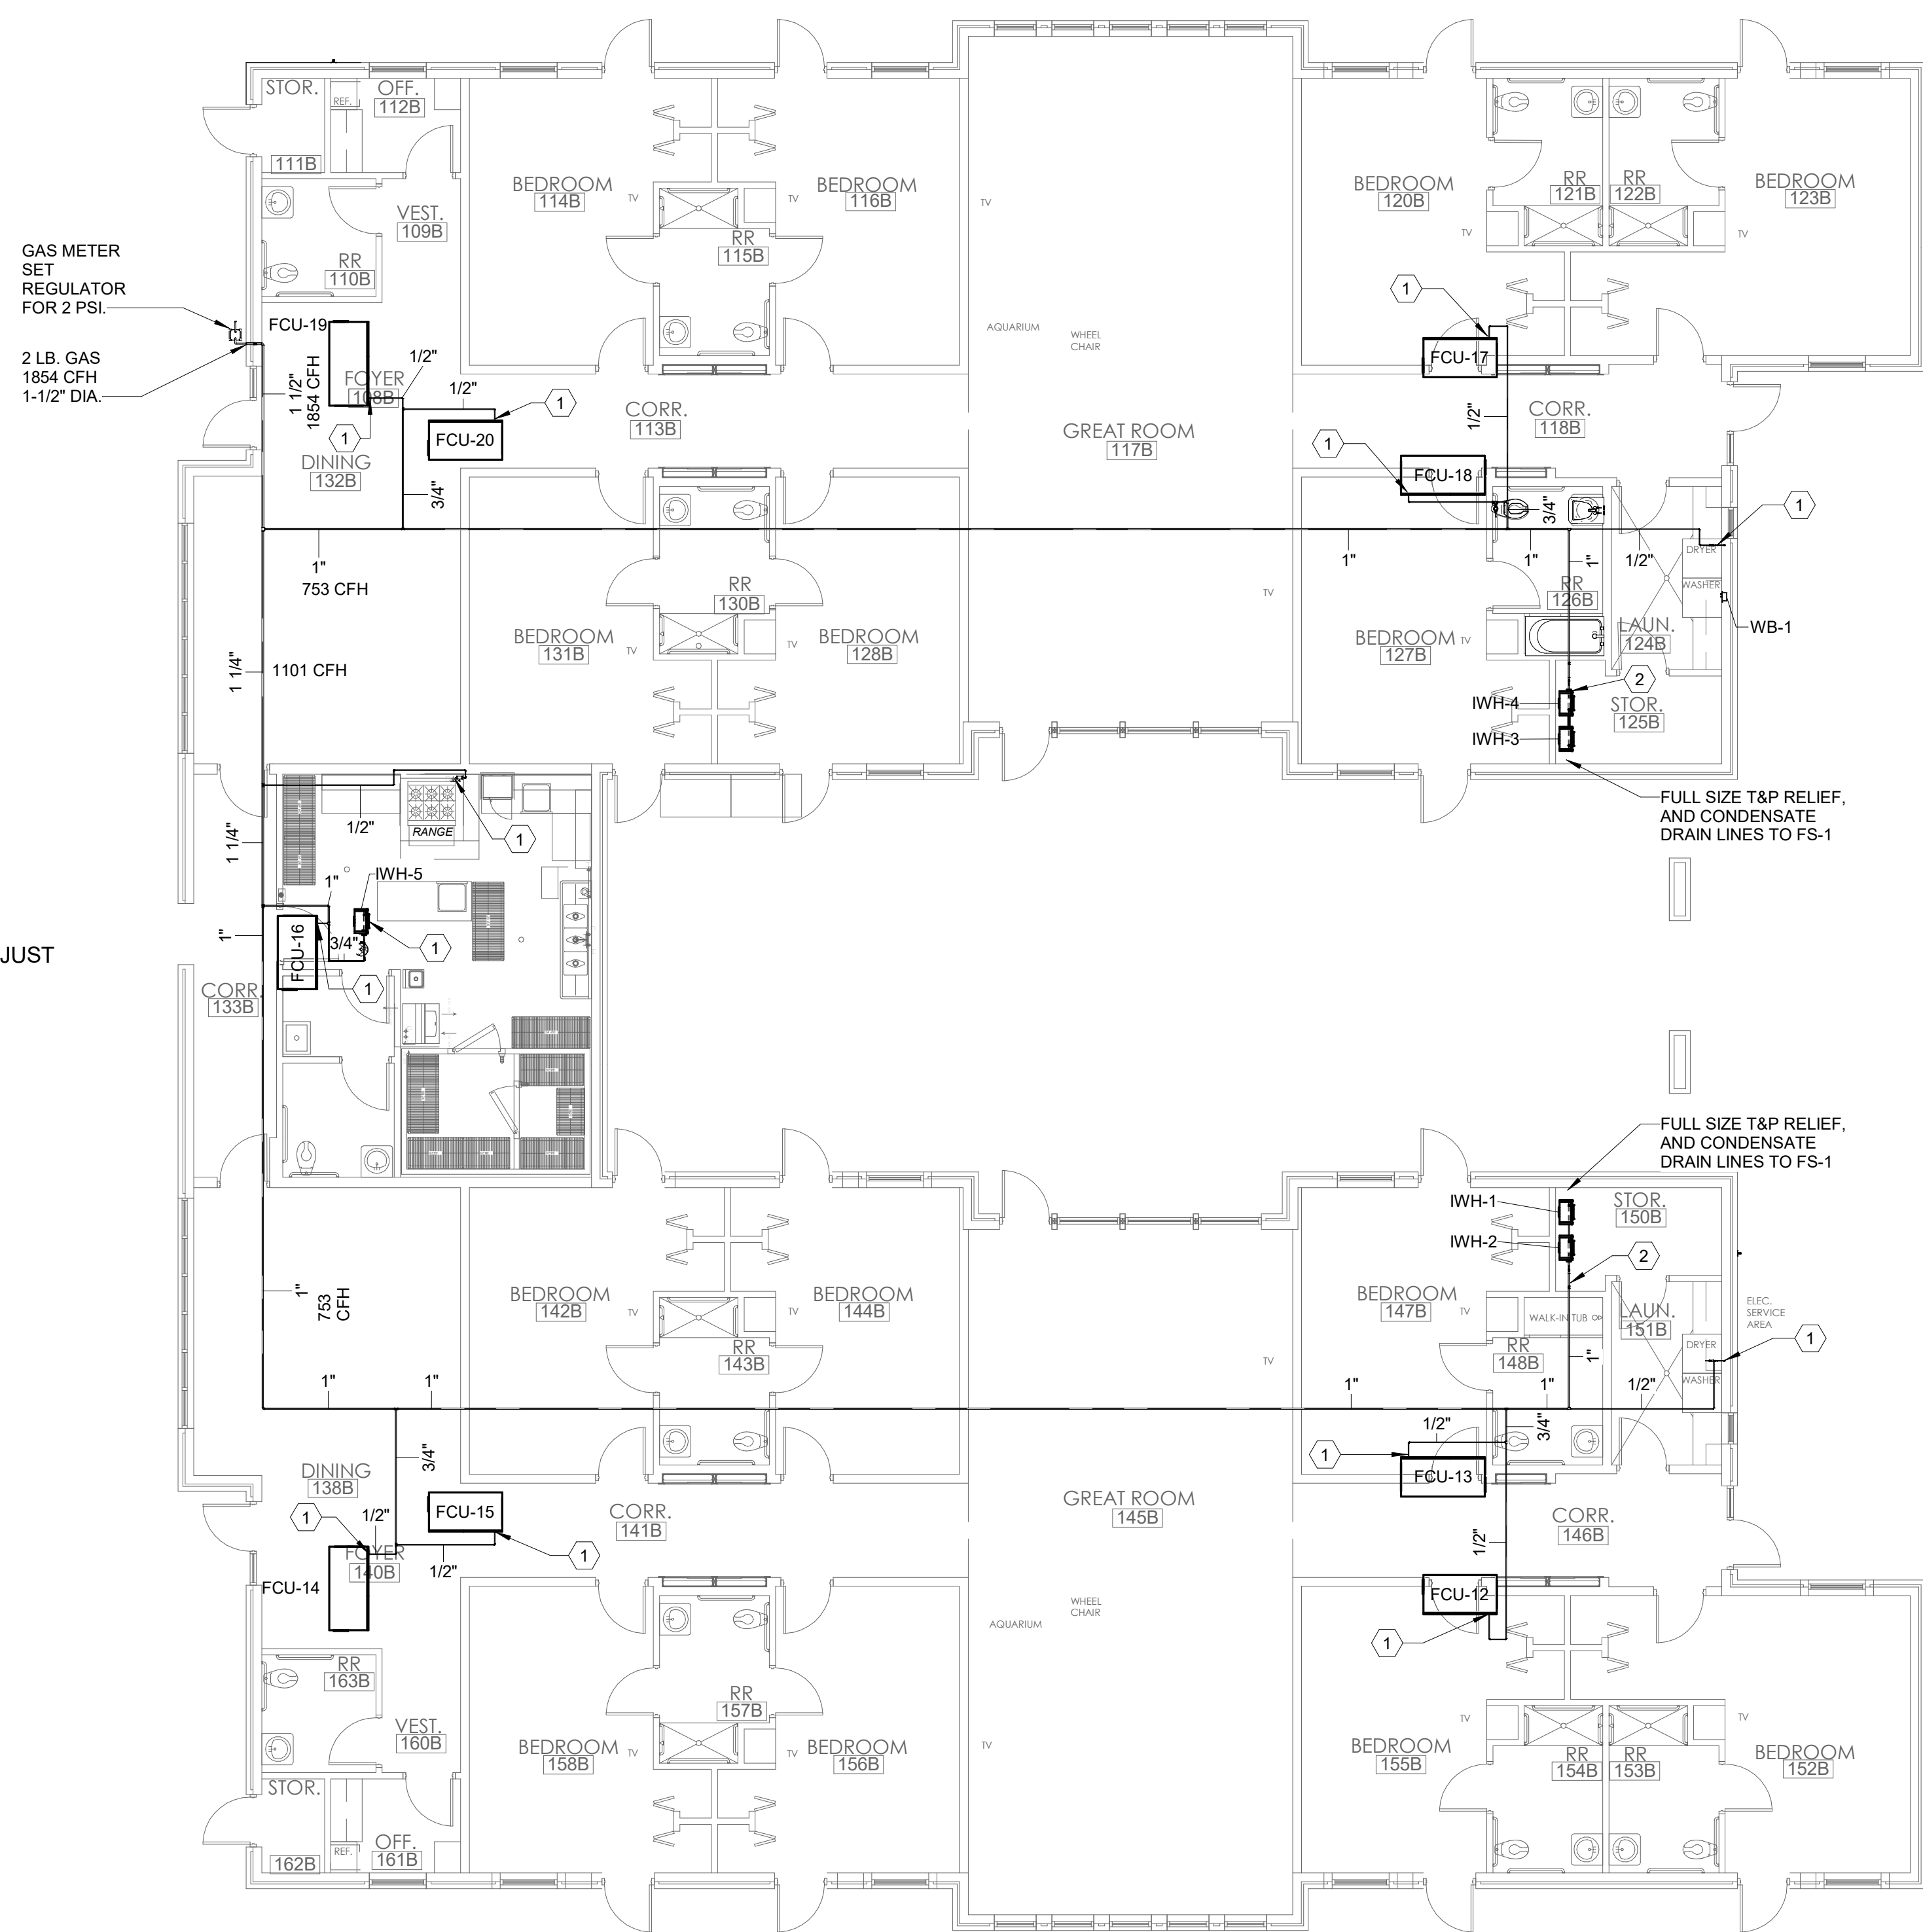


**KEYED NOTES**

- 1 PROVIDE PIETRO FIORENTINI VENTLESS GAS PRESSURE REGULATOR MODEL # 30051. ADJUST FOR 7" WATER COLUMN DELIVERY.
- 2 PROVIDE PIETRO FIORENTINI VENTLESS GAS PRESSURE REGULATOR MODEL # 30051 FOR PAIR OF WATER HEATERS. ADJUST FOR 7" WATER COLUMN DELIVERY.

**1 PLUMBING PLAN - AREA B - NATURAL GAS**  
 1/8" = 1'-0"

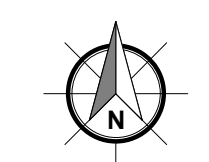

**OPTIMUM CARE  
 SUGAR LAND, TEXAS**

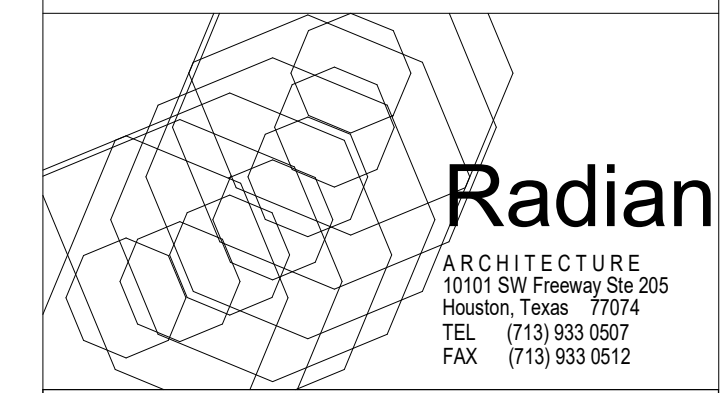

| Revision Schedule |      |                                   |
|-------------------|------|-----------------------------------|
| #                 | Date | Description                       |
| 10-26-18          |      | PERMIT, PRICING, AND CONSTRUCTION |
| 02-14-19          |      | CITY COMMENTS                     |

Project No.  
 PLUMBING NATURAL GAS PLAN  
 Sheet No.

02-18-19

**KCI**  
 TECHNOLOGIES  
 ENGINEERS  
 PLANNERS  
 SCIENTISTS  
 CONSTRUCTION MANAGERS  
 801 TRAVIS, SUITE 2000  
 HOUSTON, TX 77002  
 PHONE: 713-237-9800  
 FAX: 713-237-9801  
 Texas Registered Engineering Firm F-10573

**P1.03**