


File Name: C:\DMS\Revit\_Projects\Optimum Personal Care- Phase 2-PLBG\_paul.corley.rvt  
 User: paul.corley  
 Date/Time: 2/13/2019 1:39:09 PM

**KEYED NOTES**

- 1 PROVIDE PIETRO FIORENTINI VENTLESS GAS PRESSURE REGULATOR MODEL # 30051. ADJUST FOR 7" WATER COLUMN DELIVERY.
- 2 PROVIDE PIETRO FIORENTINI VENTLESS GAS PRESSURE REGULATOR MODEL # 30051 FOR PAIR OF WATER HEATERS. ADJUST FOR 7" WATER COLUMN DELIVERY.
- 3 PROVIDE 9" DIRT LEG AT EQUIPMENT CONNECTION.

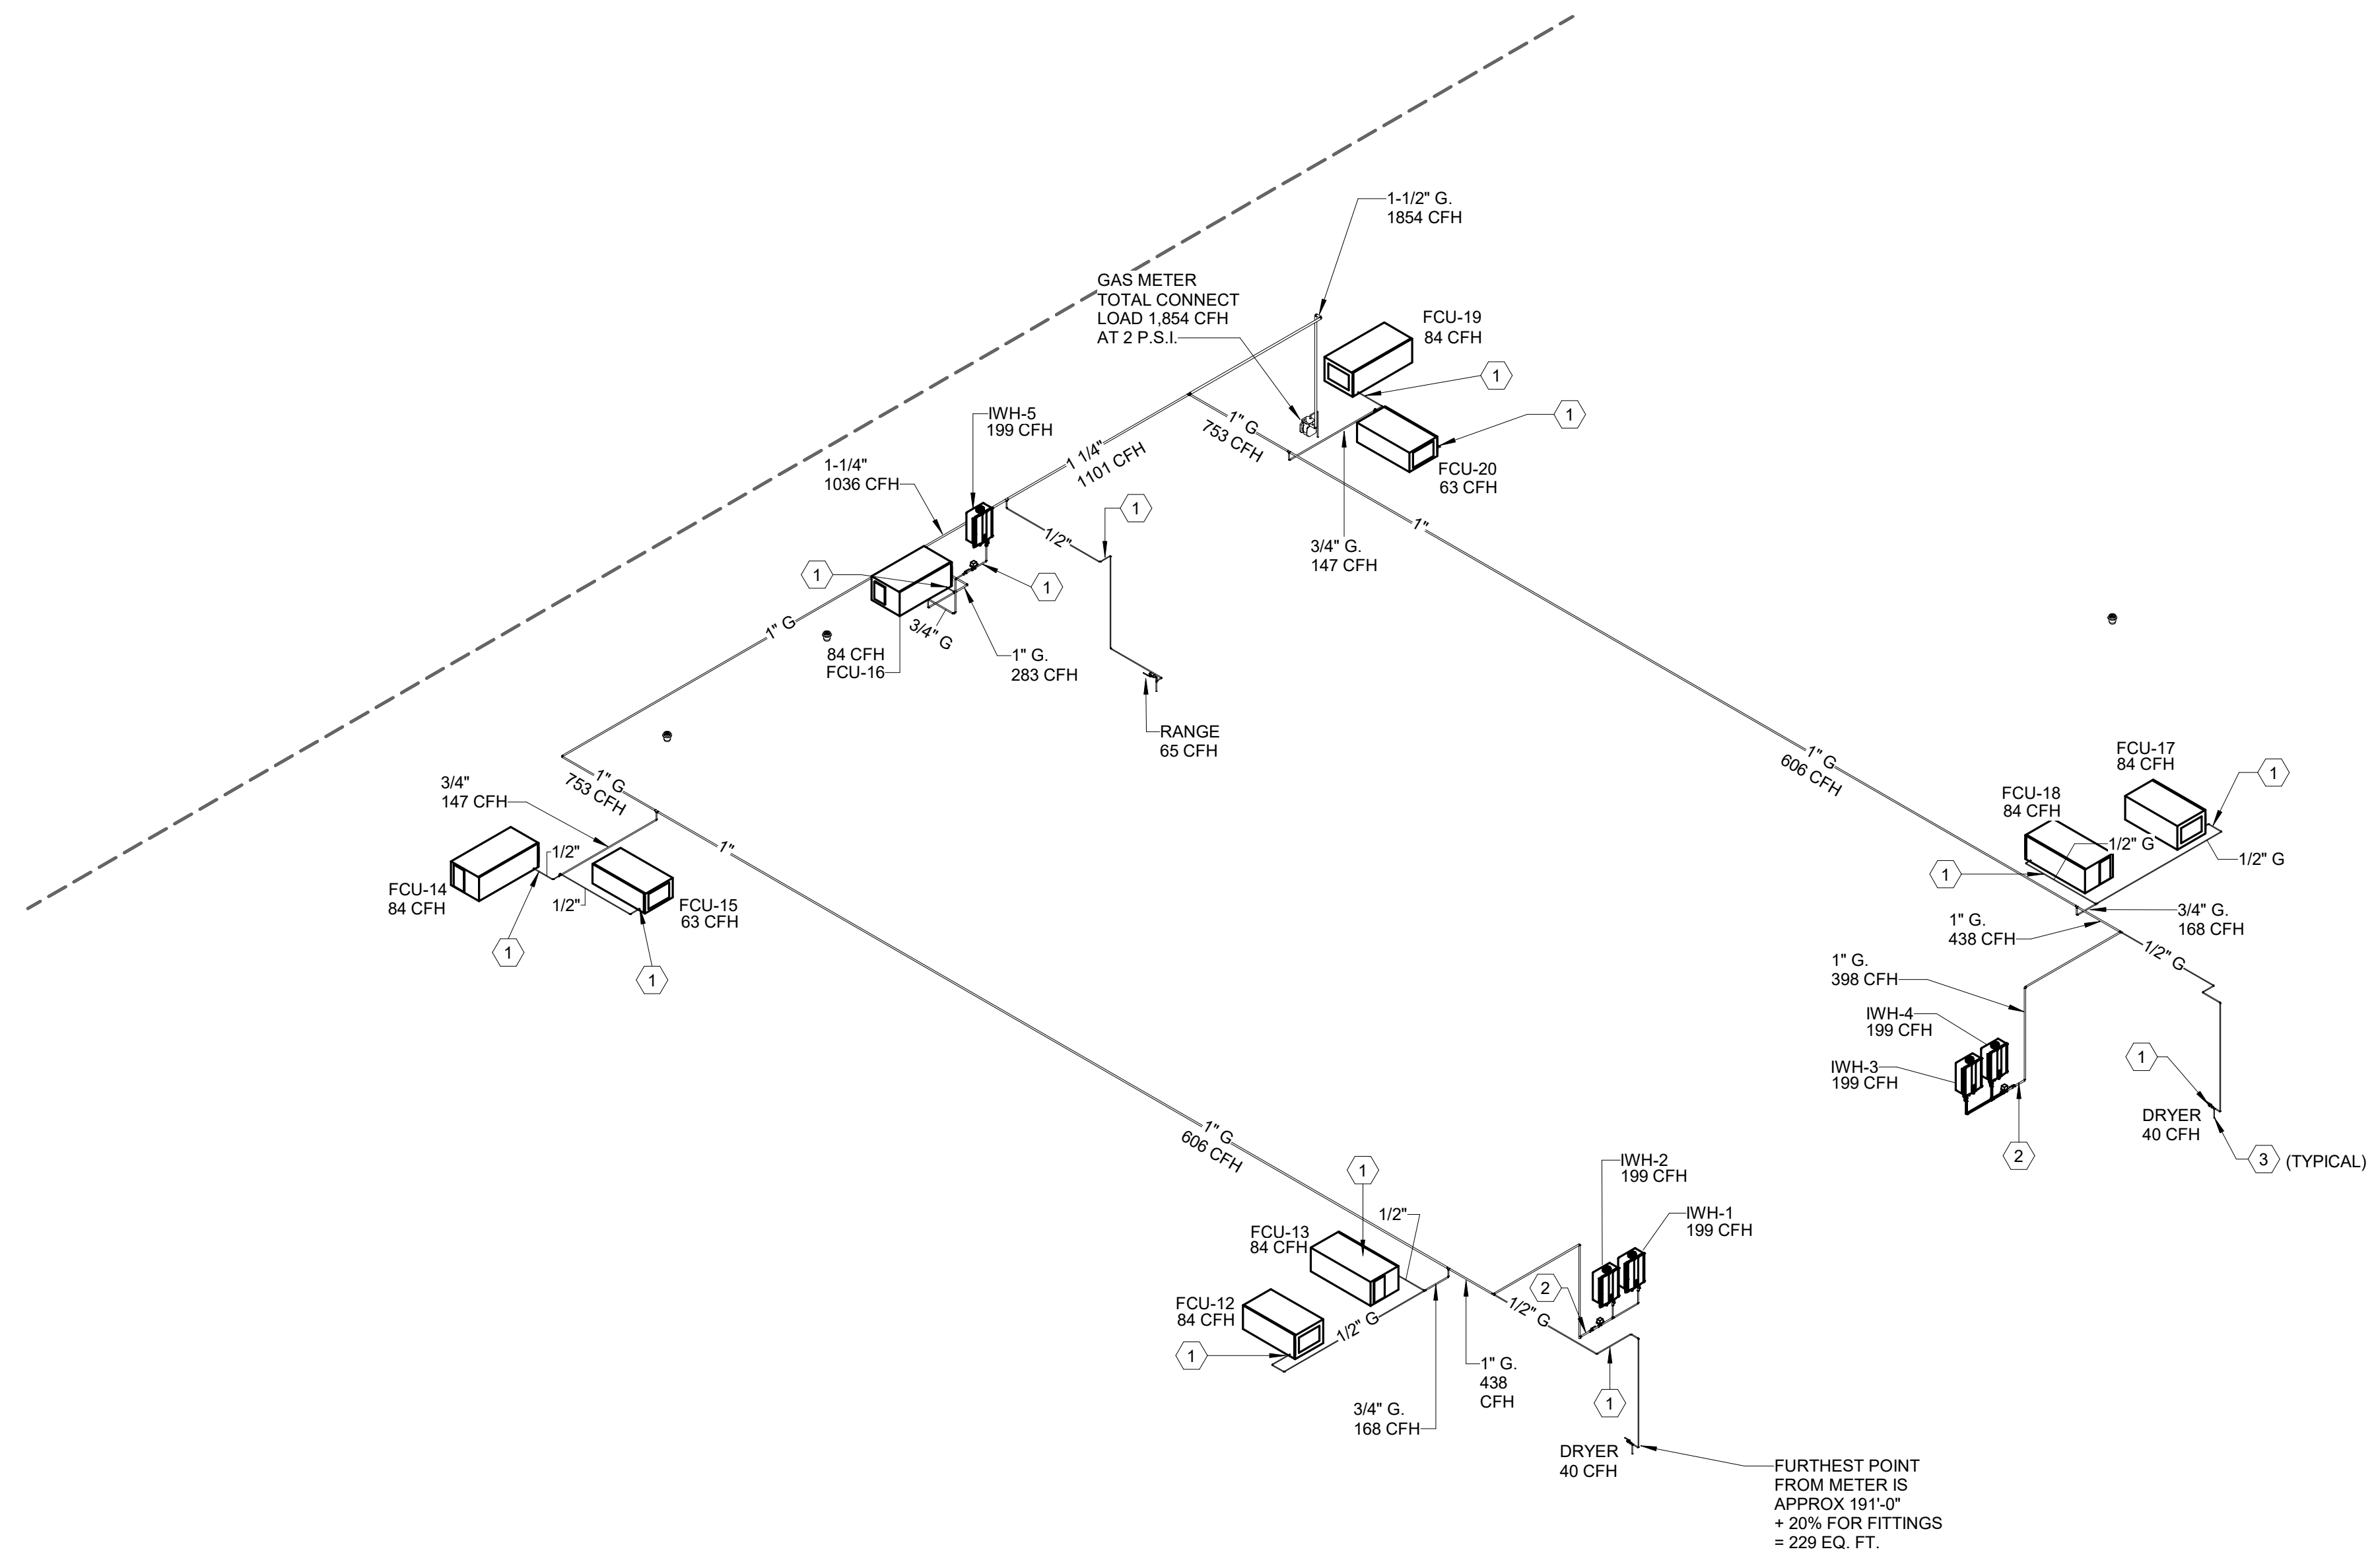


**1 PLUMBING RISER DIAGRAM - NATURAL GAS**  
 N.T.S.

**OPTIMUM CARE**  
**SUGAR LAND, TEXAS**



Revision Schedule		
#	Date	Description
10-26-18		PERMIT, PRICING, AND CONSTRUCTION
02-14-19		CITY COMMENTS

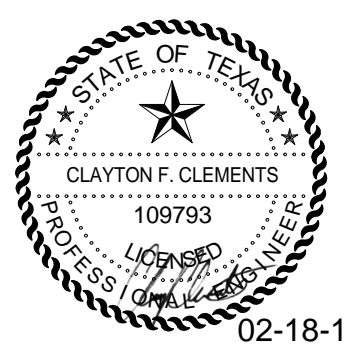

02-18-19  
**KCI** TECHNOLOGIES  
 ENGINEERS  
 PLANNERS  
 SCIENTISTS  
 CONSTRUCTION MANAGERS  
 801 TRAVIS, SUITE 2000  
 HOUSTON, TX 77002  
 PHONE: 713-237-9800  
 FAX: 713-237-9801  
 Texas Registered Engineering Firm F-10573

Project No.  
 PLBG RISER DIAGRAM - NATURAL GAS  
 Sheet No.

**P2.03**